




LEGENDA / LEGEND:

-  područje intervencije
- detalj prikazan posebno
intervention area
- detailed on separate drawing
-  D

			PROJEKAT/DESIGN: TENDERSKA DOKUMENTACIJA TENDER DOCUMENTATION		
			INVESTITOR/INVESTOR:		
ODGOVORNI PROJEKTANT/SENIOR DESIGNER: Mirjana Lazić dipl.inž.arh./MSc Arch.		BR. LICENCE/LICENCE NO.: 300 4540 03	OBJEKAT I MESTO GRADNJE/BUILDING NAME AND LOCATION: ZGRADA OPŠTINE PROKUPLJE MUNICIPAL BUILDING PROKUPLJE		
PROJEKTANT/DESIGNER:			NAZIV CRTEŽA/DRAWING NAME: SITUACIONI PLAN SITE PLAN		
SARADNIK/ASSOCIATE:					
RAZMERA/SCALE: 1:1000	BR.PROJEKTA/PROJECT NO.:	DATUM/DATE: 01.2020	BROJ CRTEŽA/DRAWING NO: 01	BR. LISTA/SHEET NO.:	BR. REV./REV. NO.: REV.0

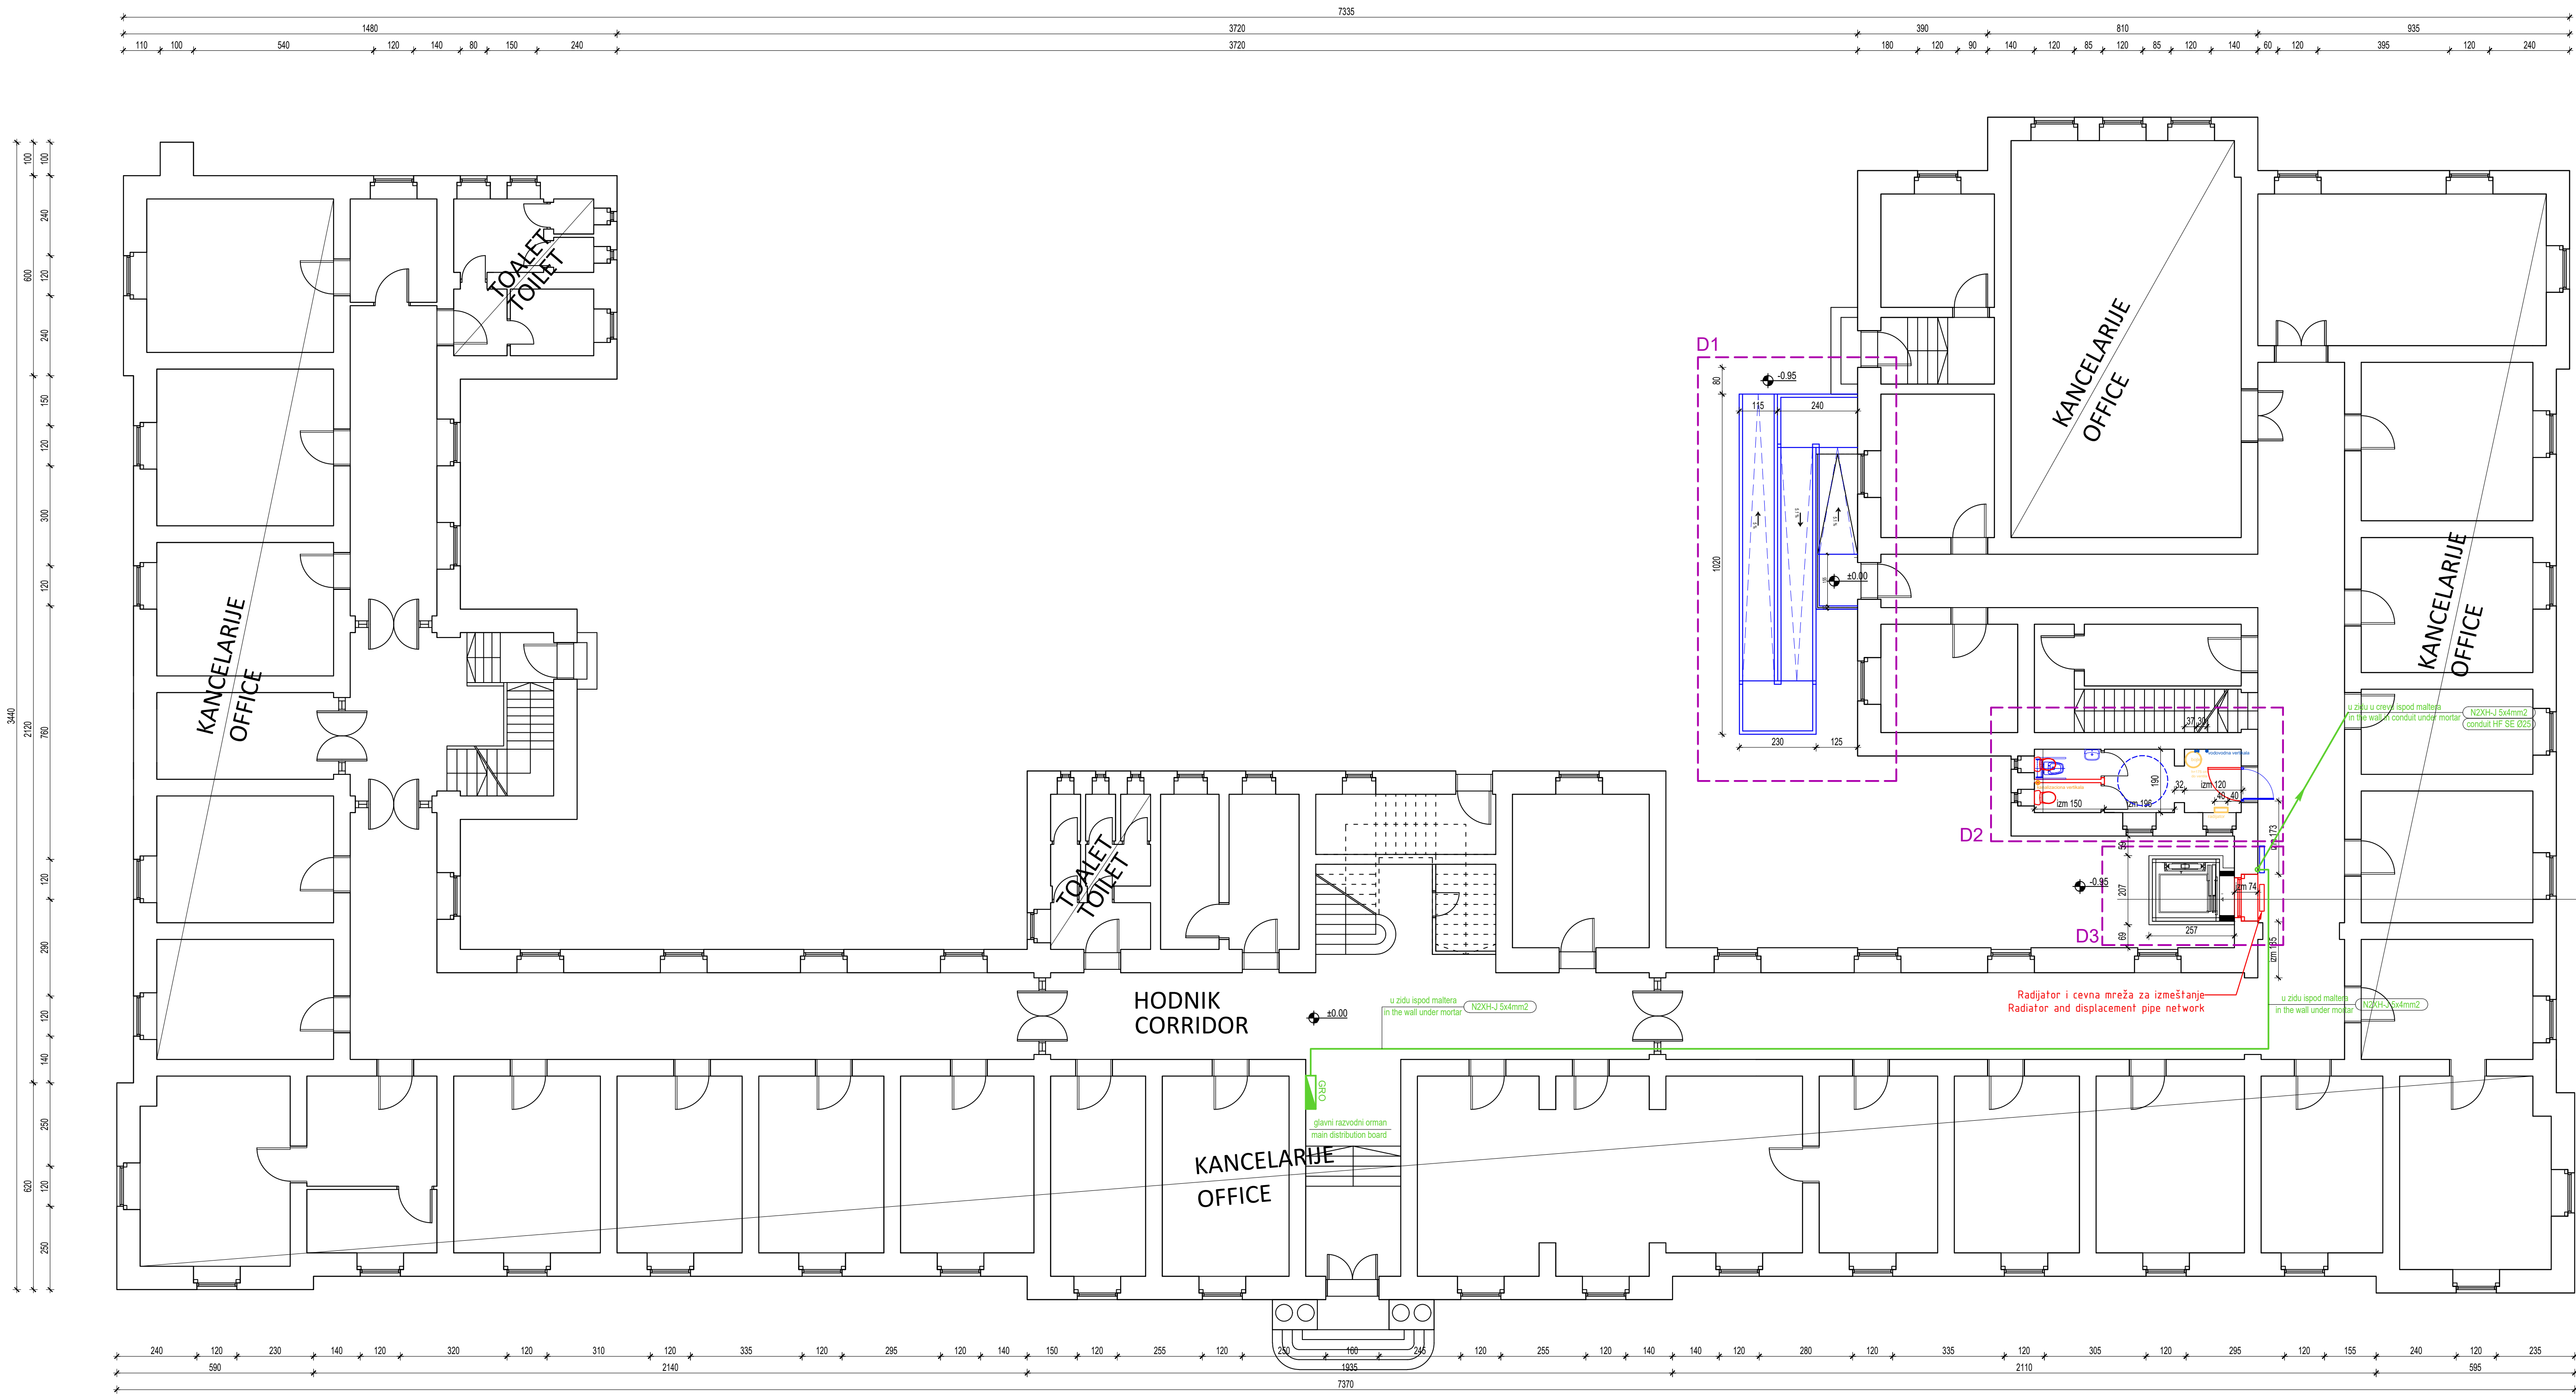

2


LEGENDA / LEGEND:

- područje intervencije
- detalj prikazan posebno
- intervention area
- detailed on separate drawing

rušenje / demolition
demontaža / disassembling

ново / new

		PROJEKT/DESIGN: TENDERSKA DOKUMENTACIJA TENDER DOCUMENTATION	
		INVESTITOR/INVESTOR:	
ODGOVORNI PROJEKTANT/SENIOR DESIGNER: Mirjana Lazić dipl.inž.arh./MSc Arch.		OBJEKAT I MESTO GRADNJE/BUILDING NAME AND LOCATION: ZGRADA OPŠTINE PROKUPLJE MUNICIPAL BUILDING PROKUPLJE	
PROJEKTANT/DESIGNER:			
PROJEKTANT/DESIGNER:		NAZIV CRTEŽA/DRAWING NAME: OSNOVA PRIZEMLJA - PLAN INTERVENCIJE GROUND FLOOR LAYOUT - INTERVENTION PLAN	
SARADNIK/ASSOCIATE:			
RAZMERA/SCALE: 1:100	BR.PROJEKTA/PROJECT NO.:	DATUM/DATE: 01-2020	BR. CRTEŽA/DRAWING NO.: 02
		BR. LISTA/SHEET NO.:	BR. REV./REV. NO.: REV.0

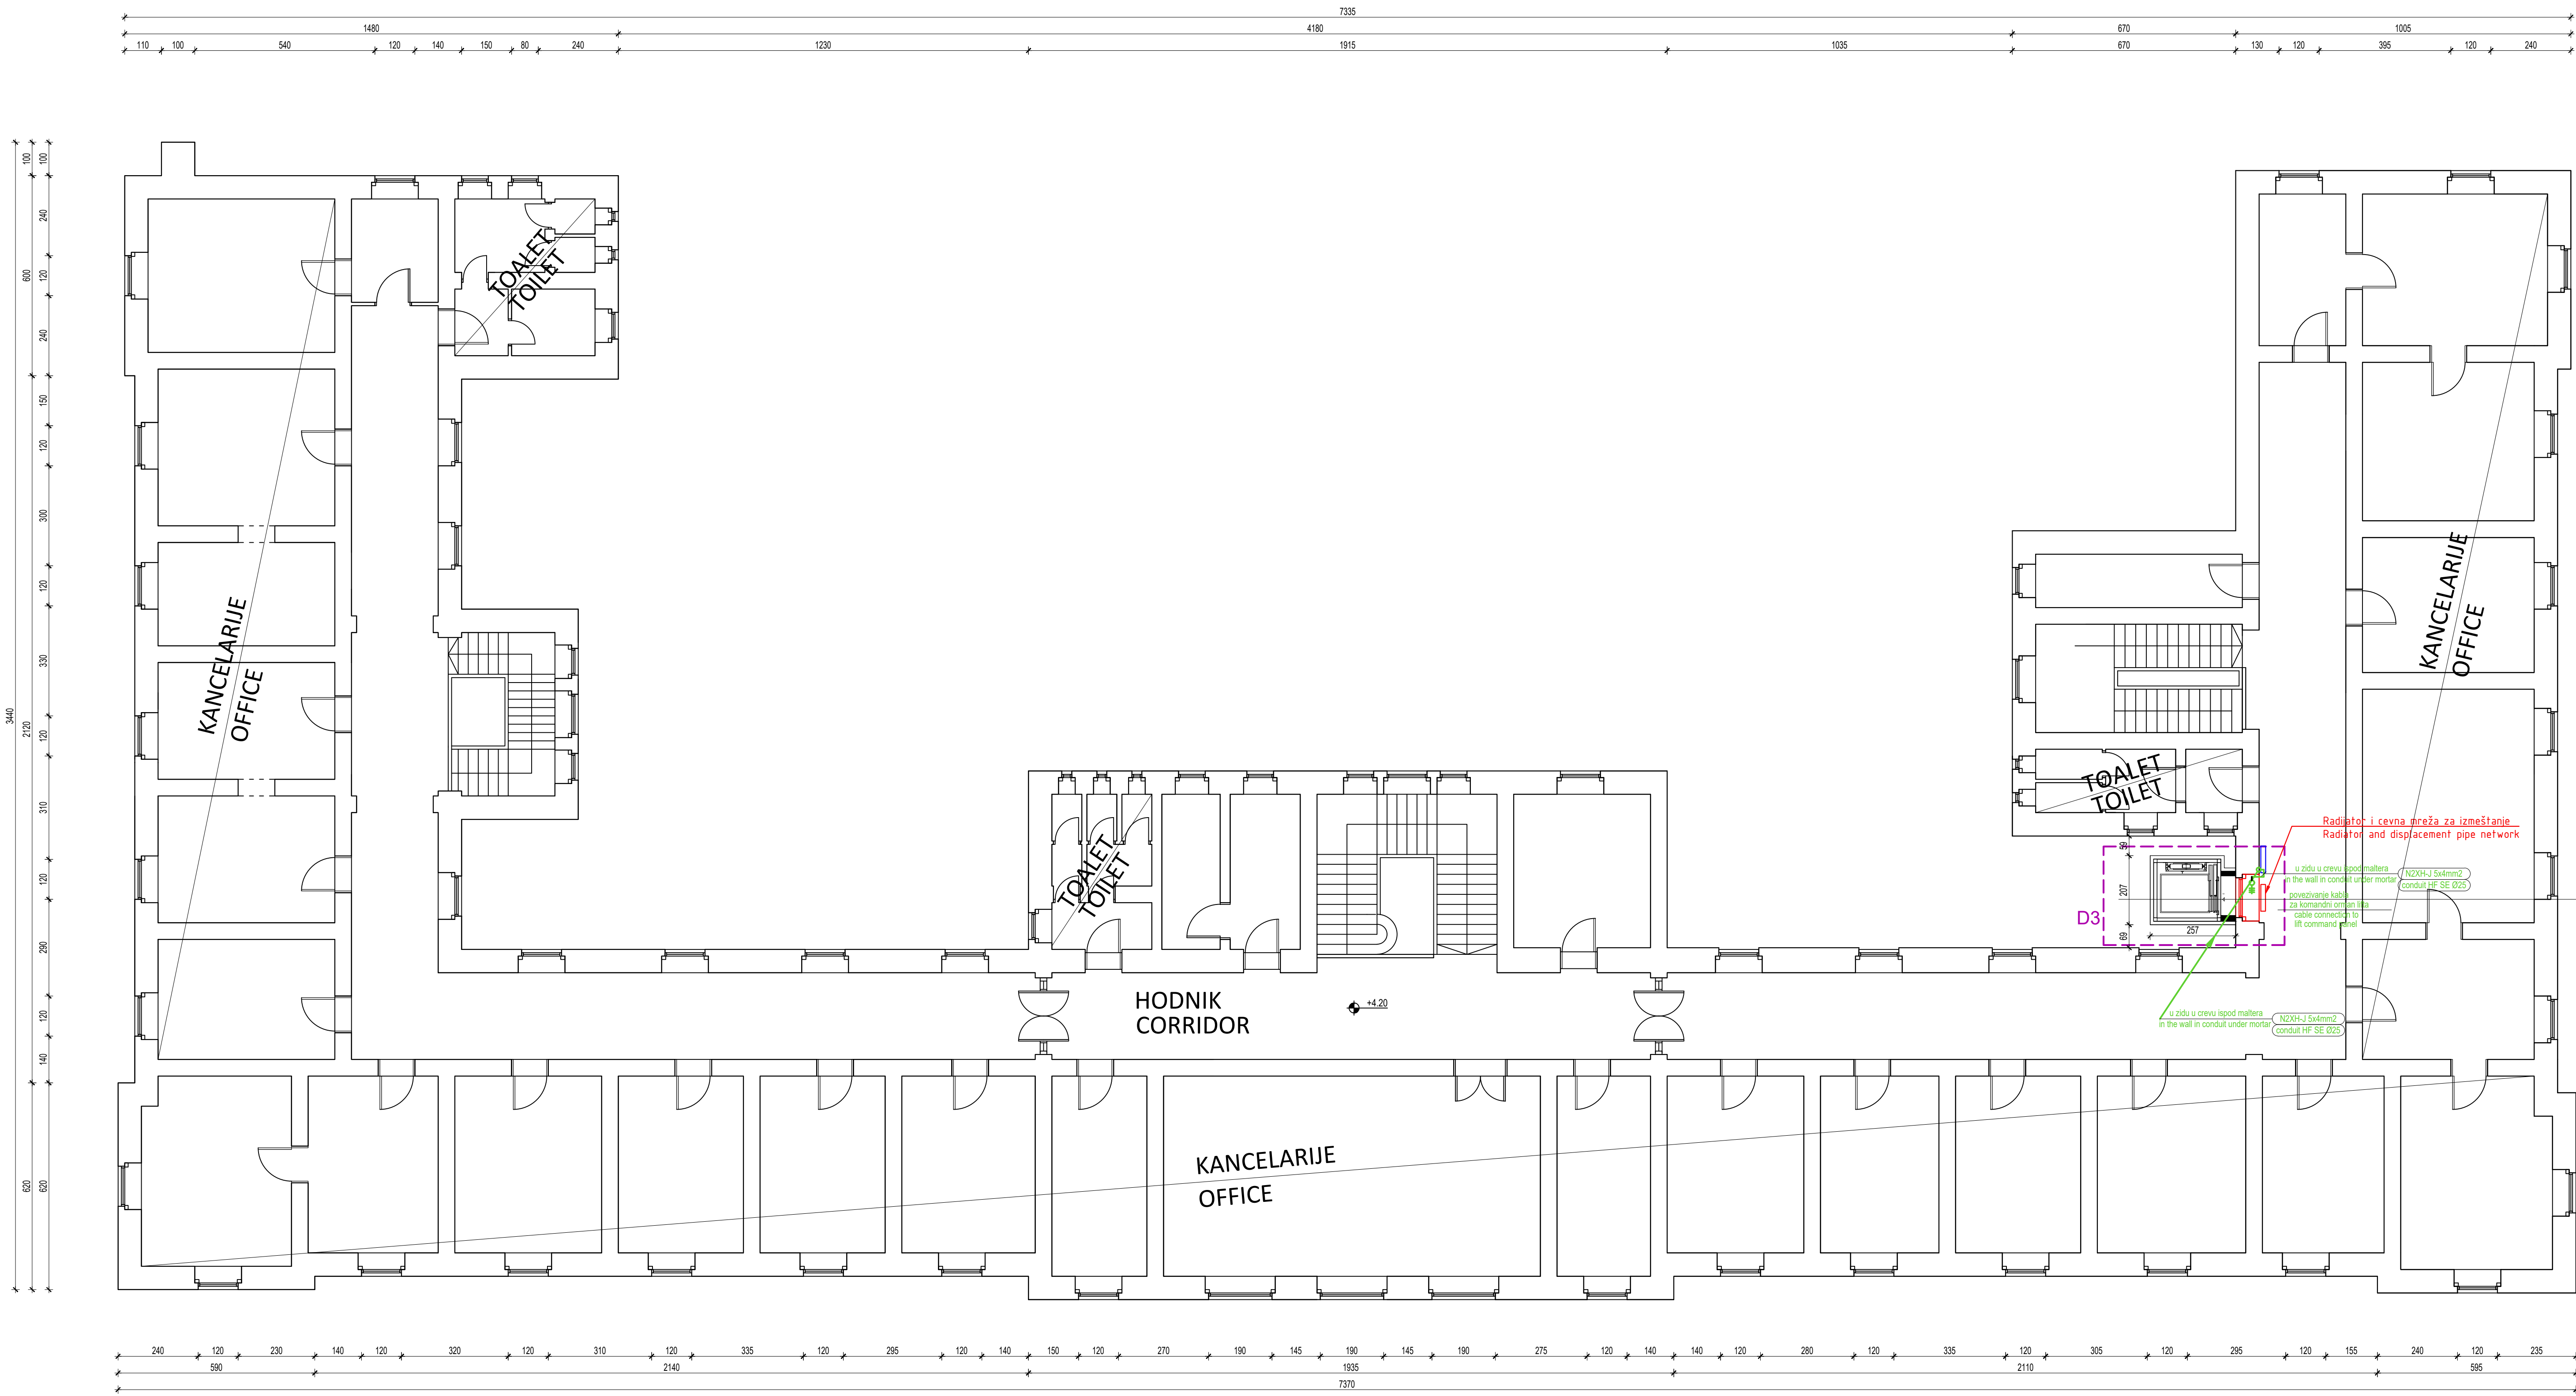


2

- LEGENDA / LEGEND:
- D3 područje intervencije
- detalj prikazan posebno
intervention area
- detailed on separate drawing
 - rušenje / demolition
demontaža / disassembling
 - novo / new


KANCELARIJE

ODGOVORNI PROJEKTANT/SENIOR DESIGNER: Mirjana Lazić dipl.inž.arh./MSc Arch.		BR. LICENCE/LICENSE NO.: 300 4540 03		PROJEKT/DESIGN: TENDERSKA DOKUMENTACIJA TENDER DOCUMENTATION	
				INVESTITOR/INVESTOR:	
PROJEKTANT/DESIGNER:				OBJEKAT I MESTO GRADNJE/BUILDING NAME AND LOCATION: ZGRADA OPŠTINE PROKUPJE MUNICIPAL BUILDING PROKUPJE	
SARADNIK/ASSOCIATE:				NAZIV CRTEŽA/DRAWING NAME: OSNOVA SPRATA - PLAN INTERVENCIJE UPPER FLOOR LAYOUT - INTERVENTION PLAN	
RAZMERA/SCALE: 1:100	BR.PROJEKTA/PROJECT NO.:	DATUM/DATE: 01-2020	BROJ CRTEŽA/DRAWING NO.:	BR. LISTA/SHEET NO.:	BR. REV./REV. NO.: REV.0

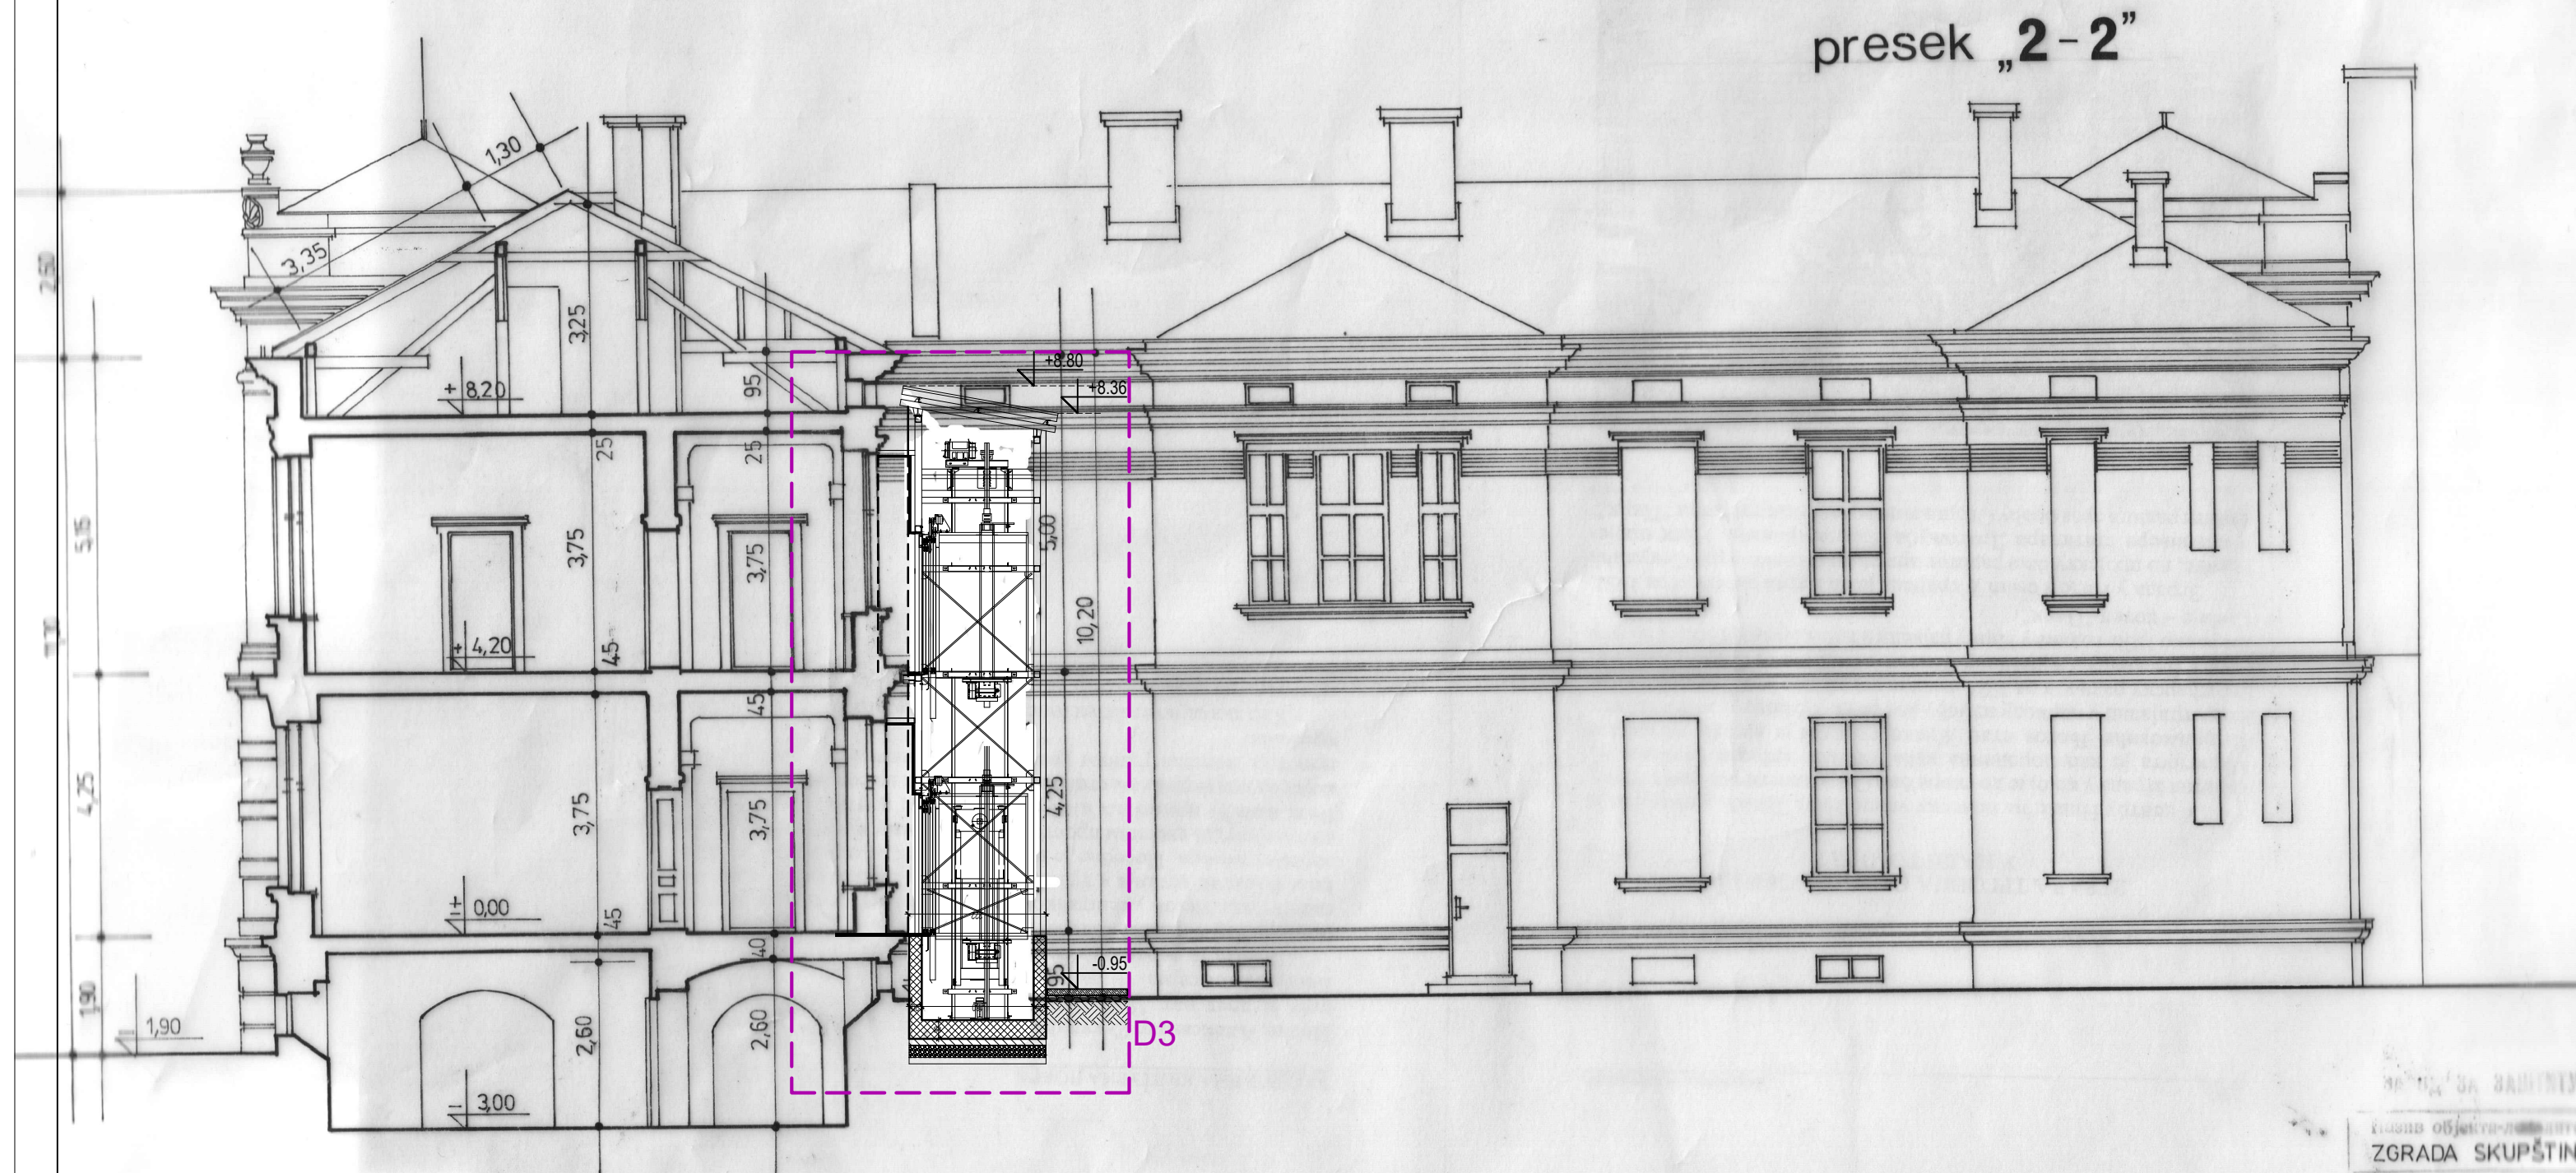


BR. 11, SA SAJITIV HODNIK
Klasirano objekat dokument
ZGRADA SKUPŠTINE OPŠTINE
Mesto, Republika
PROKUPLJE
Sadržaj:
PRESEK „1-1” „2-2”

		PROJEKAT/DESIGN: TENDERSKA DOKUMENTACIJA TENDER DOCUMENTATION		
		INVESTITOR/INVESTOR:		
ODGOVORNI PROJEKTANT/SENIOR DESIGNER: Mirjana Lazić dipl.inž.arh./MSc Arch.		BR. LICENCE/LICENCE NO.: 300 4540 03	OBJEKAT I MESTO GRADNJE/BUILDING NAME AND LOCATION: ZGRADA OPŠTINE PROKUPLJE MUNICIPAL BUILDING PROKUPLJE	
PROJEKTANT/DESIGNER:				
PROJEKTANT/DESIGNER:			NAZIV CRTEŽA/DRAWING NAME: PRESEK 2-2 SECTION 2-2	
SARADNIK/ASSOCIATE:				
RAZMERA/SCALE: 1:100	BR.PROJEKTA/PROJECT NO.:	DATUM/DATE: 01-2020	BROJ CRTEŽA/DRAWING NO.: 04	BR. LISTA/SHEET NO.: REV.0

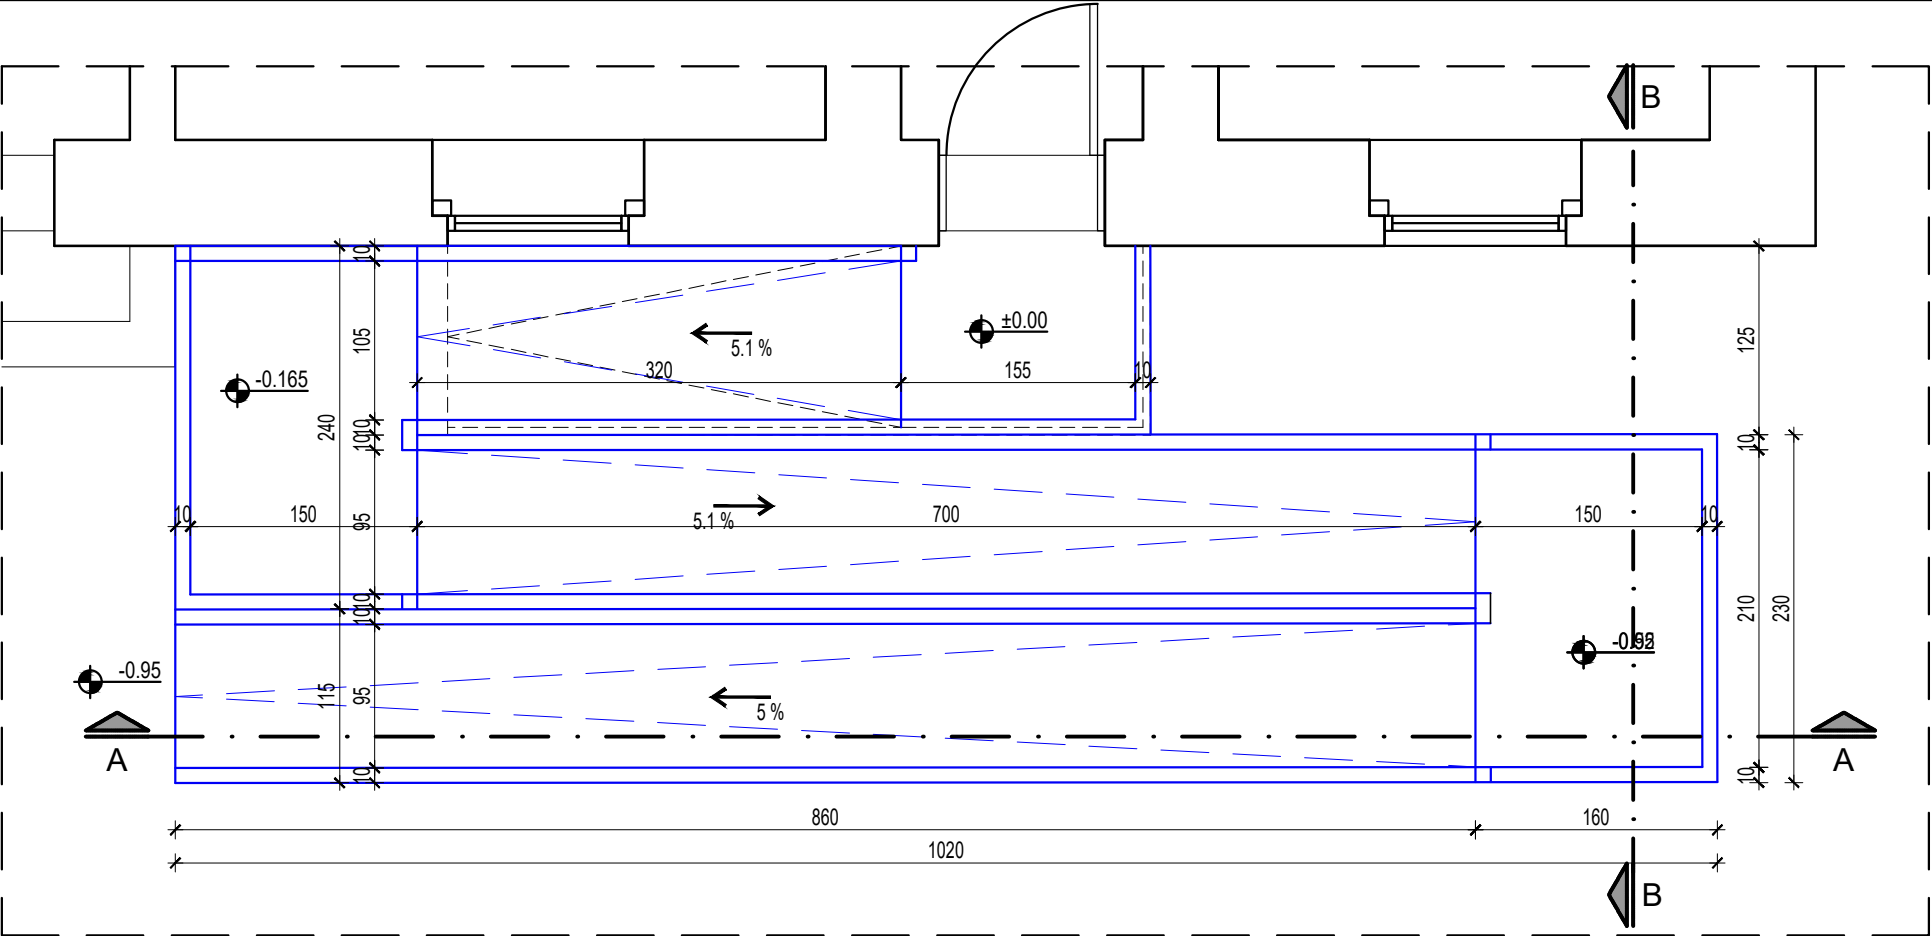

NOVOPROJEKTOVANO
NEWLY DESIGNED

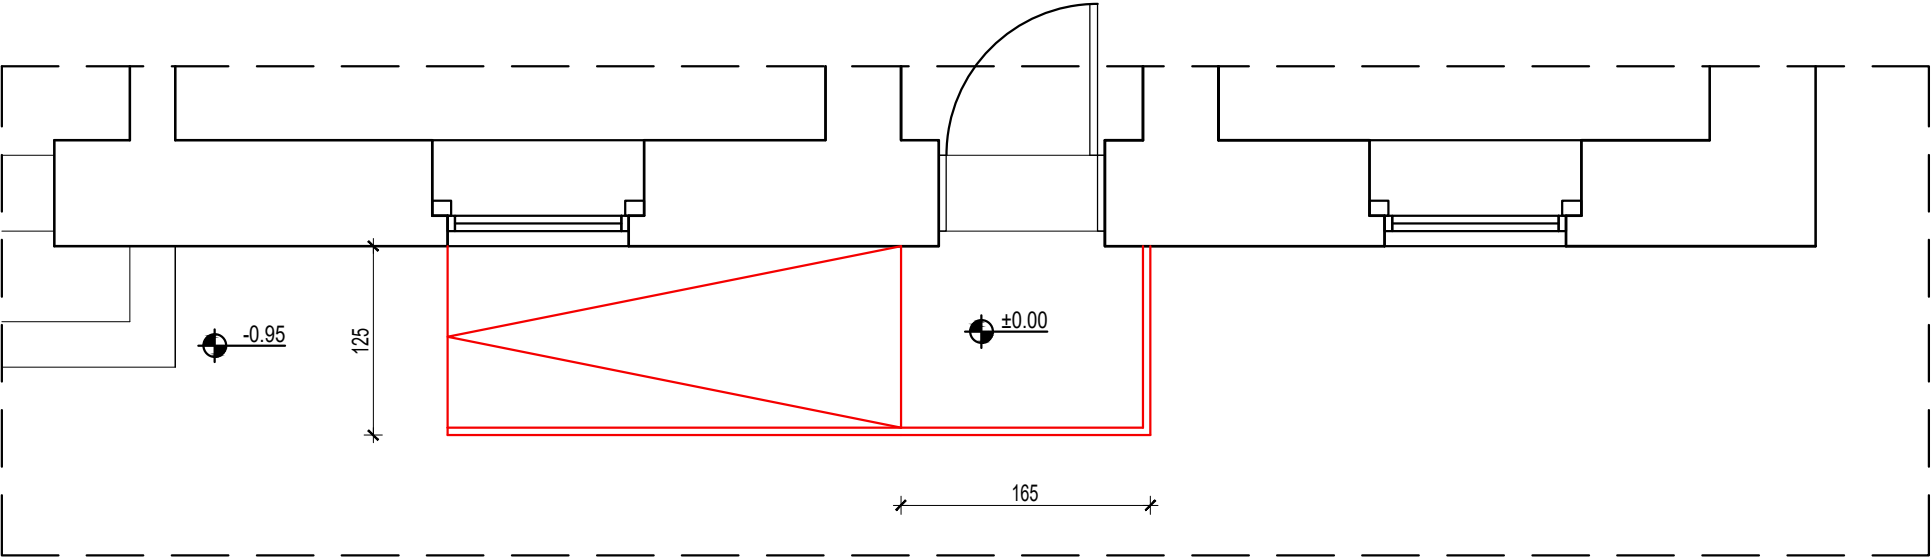


POSTOJEĆE STANJE
EXISTING STATE



 
 
 
- LEGENDA / LEGEND:
- rušenje / demolition
demontaža / disassembling
 - trotoar za rušenje
pavement to be demolished
 - novo / new
 - nov trotoar
new pavement


			PROJEKAT/DESIGN: TENDERSKA DOKUMENTACIJA TENDER DOCUMENTATION		
			INVESTITOR/INVESTOR:		
ODGOVORNI PROJEKTANT/SENIOR DESIGNER: Mirjana Lazić dipl.inž.arh./MSc Arch.		BR. LICENCE/LICENCE NO.: 300 4540 03	OBJEKAT I MESTO GRADNJE/BUILDING NAME AND LOCATION: ZGRADA OPŠTINE PROKUPLJE MUNICIPAL BUILDING PROKUPLJE		
PROJEKTANT/DESIGNER:					
PROJEKTANT/DESIGNER:			NAZIV CRTEŽA/DRAWING NAME: DETALJ D1 - ULAZNA RAMPA - OSNOVE DETAIL D1 - ENTRANCE RAMP - LAYOUT		
SARADNIK/ASSOCIATE:					
RAZMERA/SCALE: 1:50	BR.PROJEKTA/PROJECT NO.:	DATUM/DATE: 01-2019	BROJ CRTEŽA/DRAWING NO: 05	BR. LISTA/SHEET NO.: 1	BR. REV./REV. NO.: REV.0

LEGENDA / LEGEND:


 novo / new

LEGENDA / LEGEND:

-  armirani beton / reinforced concrete
-  tampon sloj šljunka / compact gravel basis
-  nabijena zemlja / compact soil
-  postojeći teren / existing level line
-  hidroizolacioni premaz / waterproofing layer

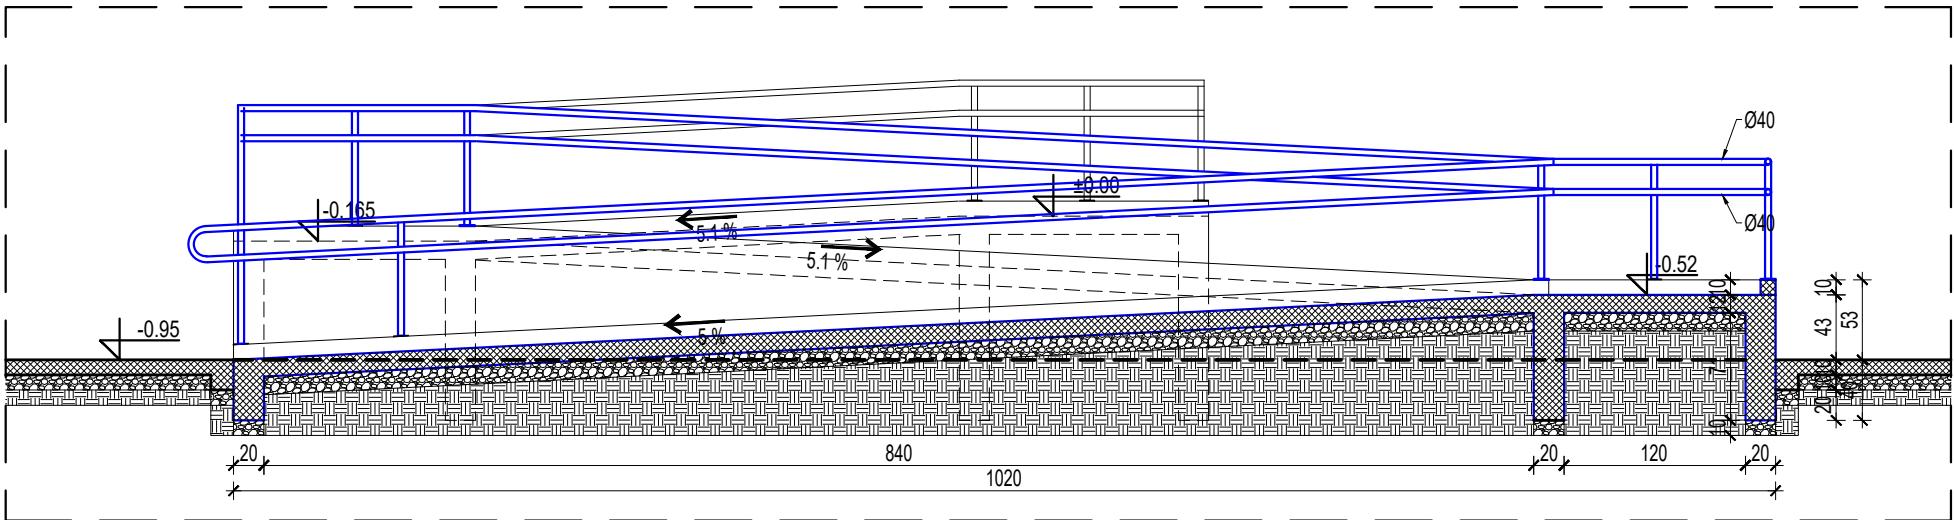


PRESEK B-B
SECTION B-B

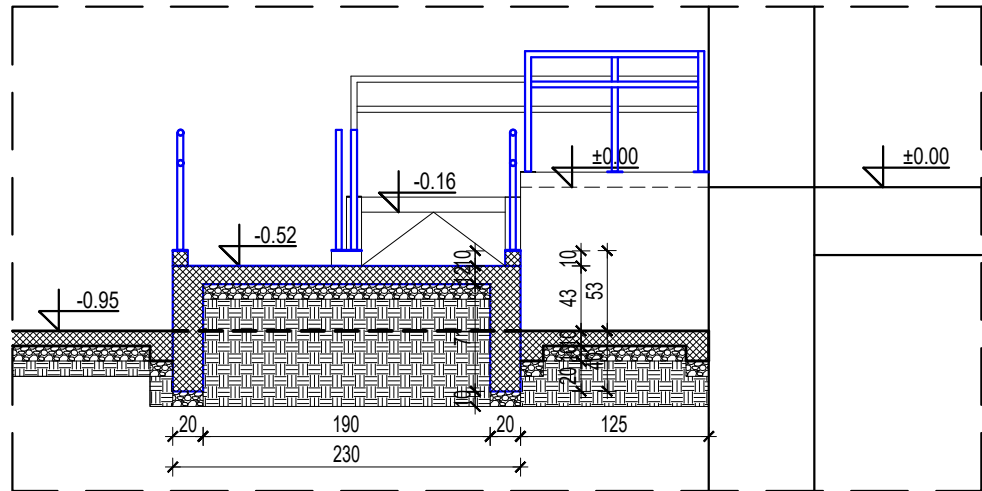


PRESEK A-A
SECTION A-A

			PROJEKAT/DESIGN: TENDERSKA DOKUMENTACIJA TENDER DOCUMENTATION		
			INVESTITOR/INVESTOR:		
ODGOVORNI PROJEKTANT/SENIOR DESIGNER: Mirjana Lazić dipl.inž.arh./MSc Arch.		BR. LICENCE/LICENCE NO.: 300 4540 03	OBJEKAT I MESTO GRADNJE/BUILDING NAME AND LOCATION: ZGRADA OPŠTINE PROKUPLJE		
PROJEKTANT/DESIGNER:			MUNICIPAL BUILDING PROKUPLJE		
PROJEKTANT/DESIGNER:			NAZIV CRTEŽA/DRAWING NAME:		
SARADNIK/ASSOCIATE:			DETALJ D1 - ULAZNA RAMPA - PRESECI		
			DETAIL D1 - ENTRANCE RAMP - SECTIONS		
RAZMERA/SCALE: 1:50	BR.PROJEKTA/PROJECT NO.:	DATUM/DATE: 01-2019	BROJ CRTEŽA/DRAWING NO: 06	BR. LISTA/SHEET NO.: 2	BR. REV./REV. NO.: REV.0

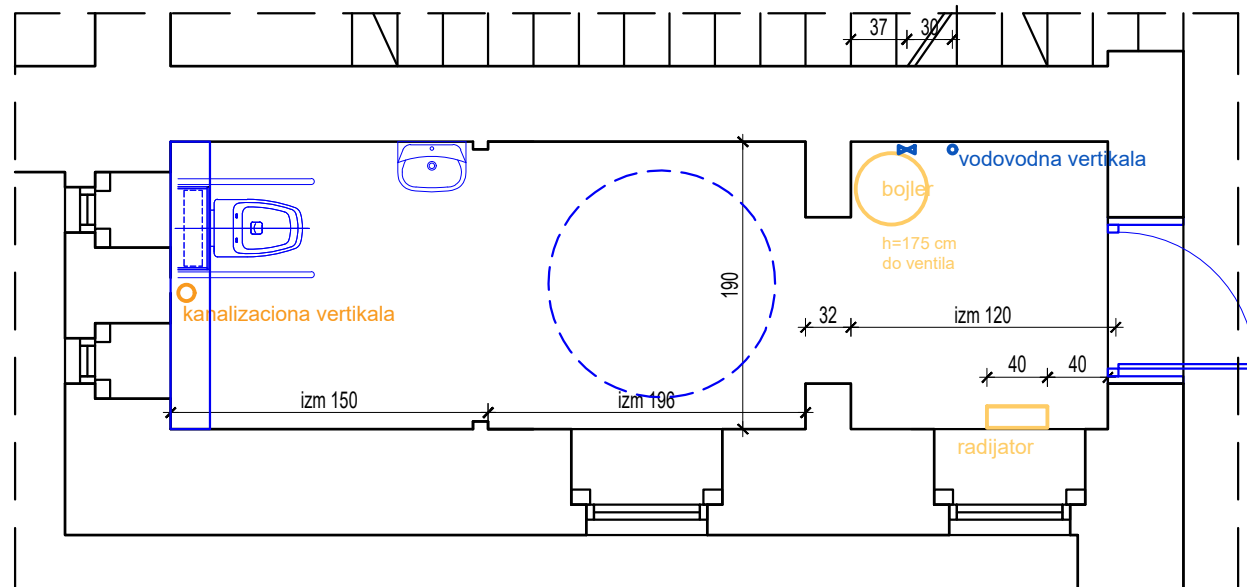

NOVOPROJEKTOVANO
NEWLY DESIGNED



- LEGENDA / LEGEND:
- rušenje / demolition
demontaža / disassembling
 - trotoar za rušenje
pavement to be demolished
 - novo / new
 - nov trotoar
new pavement

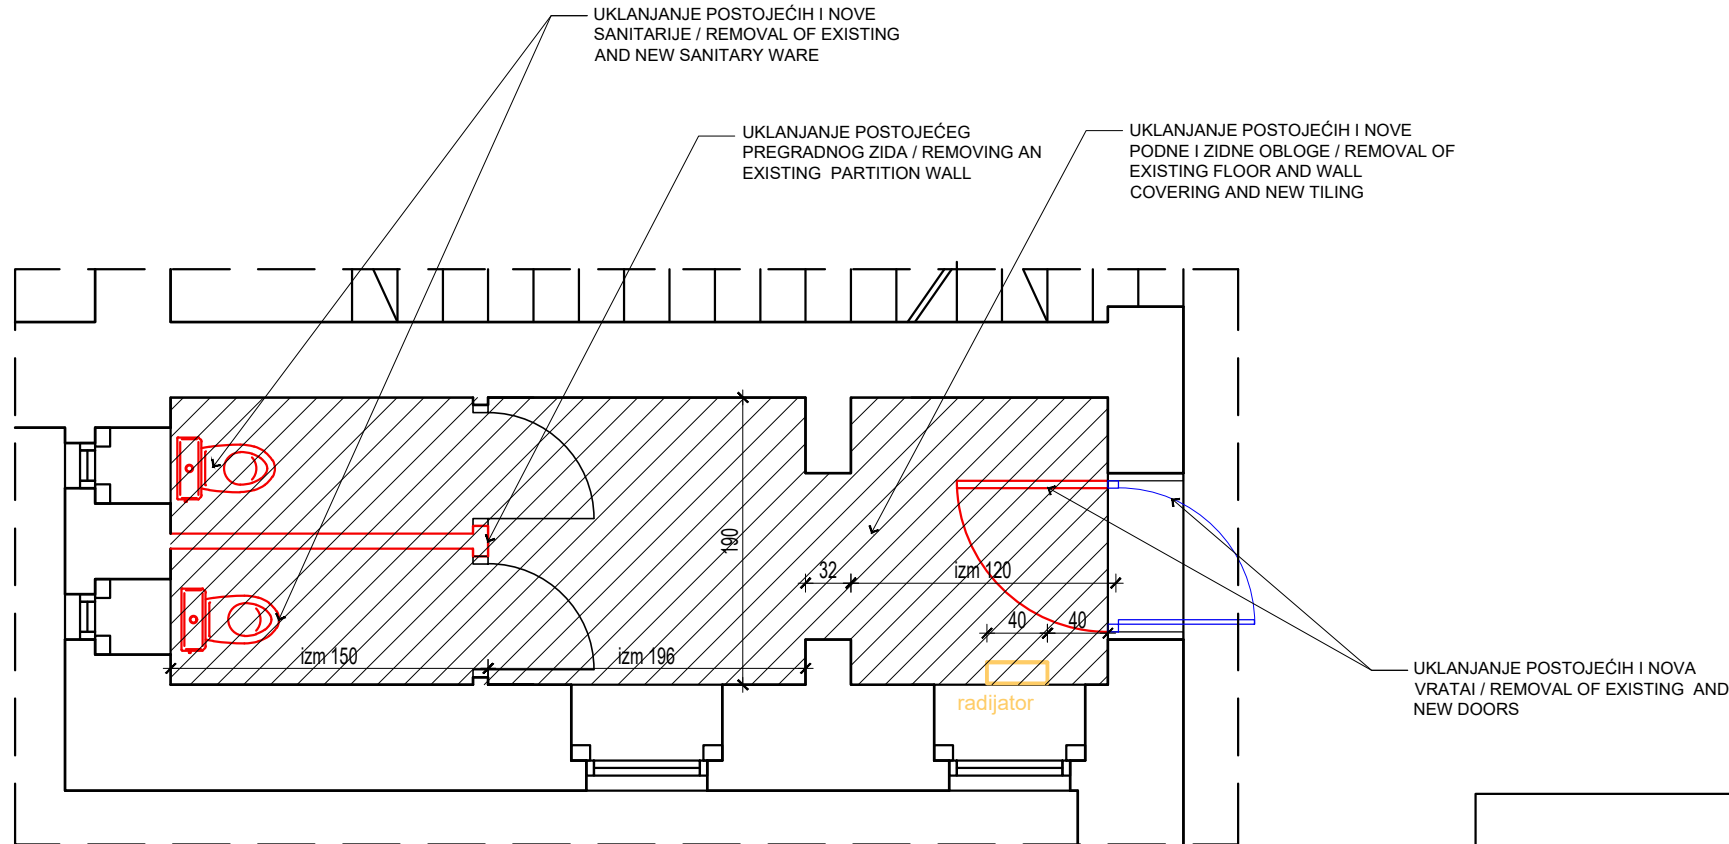

POSTOJEĆE STANJE
EXISTING STATE

Predvideti / to provide: -novu elektroinstalaciju sa rasvetom i SOS signalizacijom
/ new electrical instalation with lights and SOS signalling
-novu hidroinstalaciju -zamenu razvoda i sanitarija
/ new hydro instalation - replacement of pipes and sanitary ware

			PROJEKAT/DESIGN: TENDERSKA DOKUMENTACIJA TENDER DOCUMENTATION		
			INVESTITOR/INVESTOR:		
ODGOVORNI PROJEKTANT/SENIOR DESIGNER: Mirjana Lazić dipl.inž.arh./MSc Arch.		BR. LICENCE/LICENCE NO.: 300 4540 03	OBJEKAT I MESTO GRADNJE/BUILDING NAME AND LOCATION: ZGRADA OPŠTINE PROKUPLJE MUNICIPAL BUILDING PROKUPLJE		
PROJEKTANT/DESIGNER:					
PROJEKTANT/DESIGNER:			NAZIV CRTEŽA/DRAWING NAME: DETALJ D2 - TOALET DETAIL D2 - TOILET		
SARADNIK/ASSOCIATE:					
RAZMERA/SCALE: 1:50	BR.PROJEKTA/PROJECT NO.:	DATUM/DATE: 01-2020	BROJ CRTEŽA/DRAWING NO.: 07	BR. LISTA/SHEET NO.: 1	BR. REV./REV. NO.: REV.0

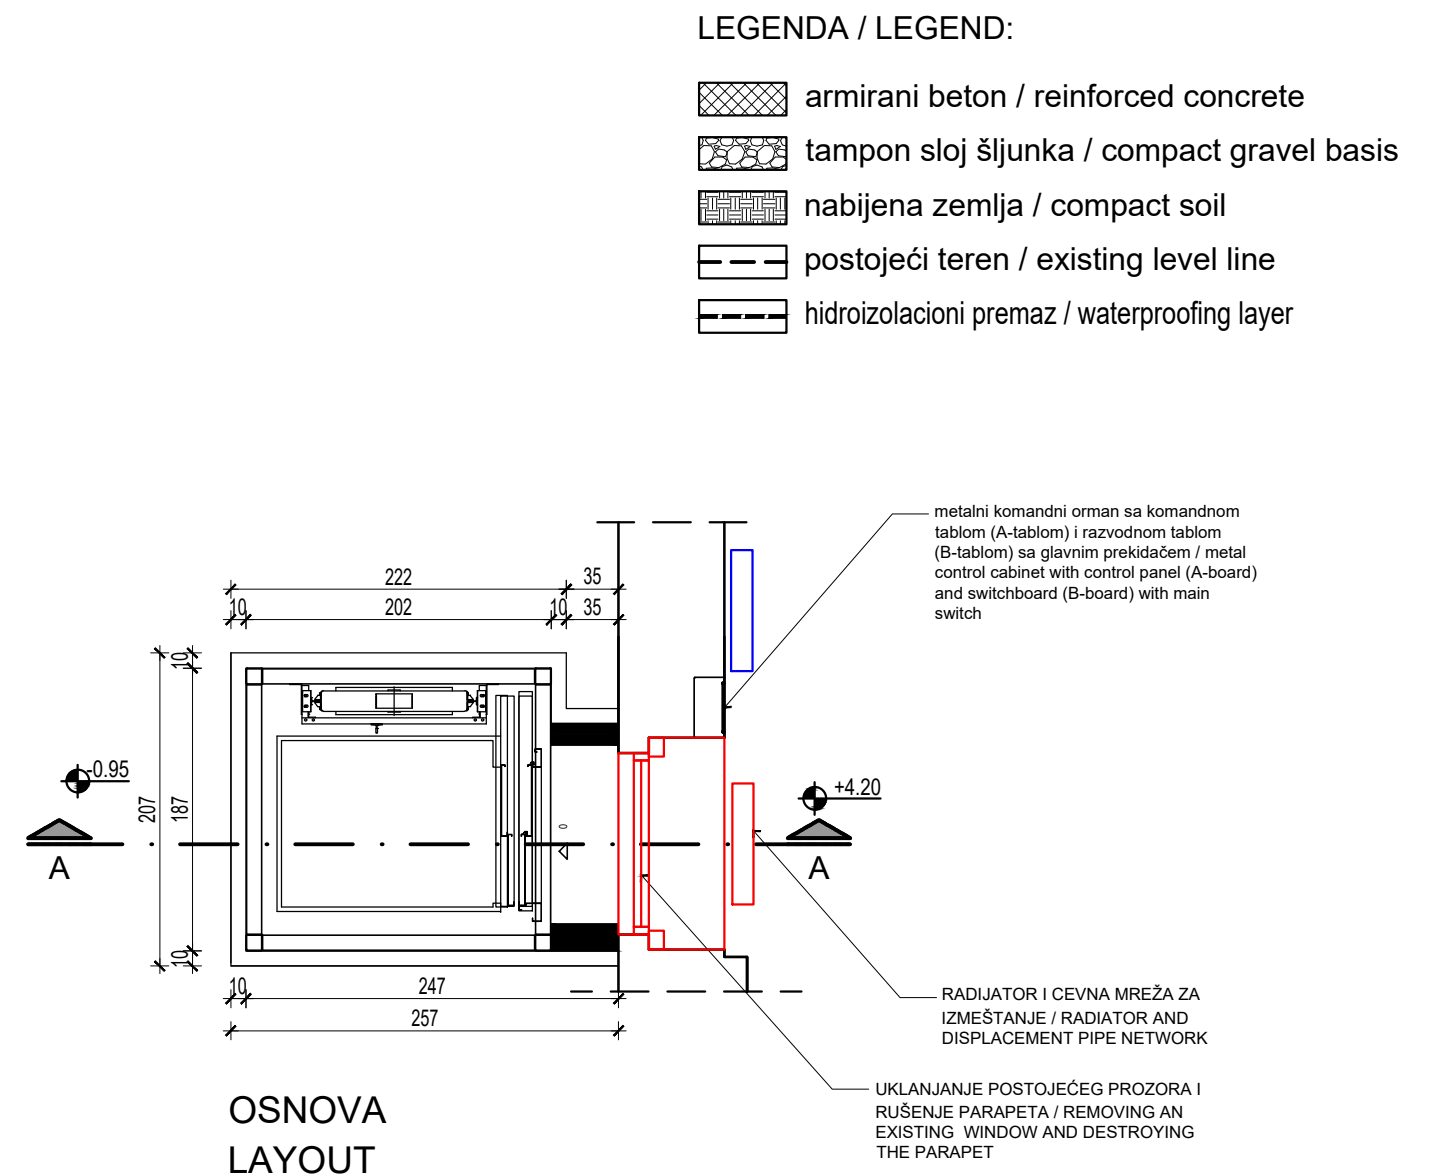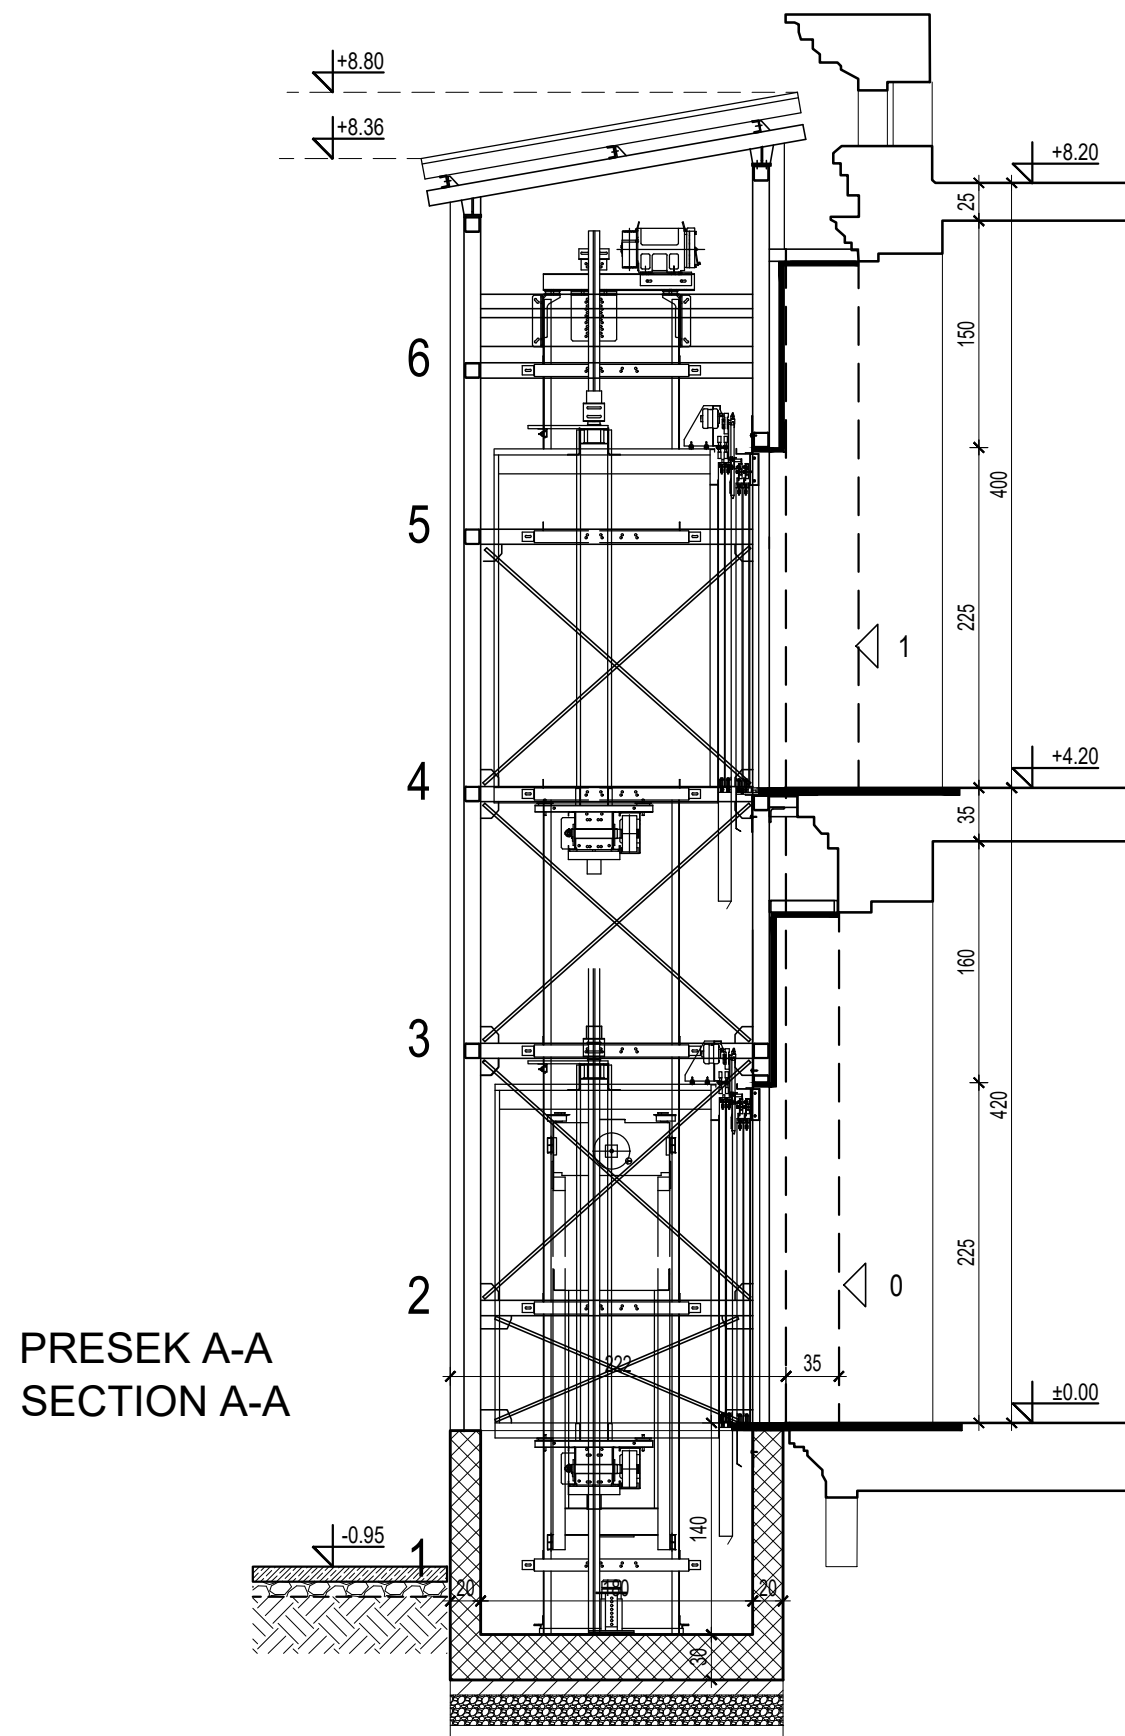

			PROJEKAT/DESIGN: TENDERSKA DOKUMENTACIJA TENDER DOCUMENTATION		
			INVESTITOR/INVESTOR:		
ODGOVORNI PROJEKTANT/SENIOR DESIGNER: Mirjana Lazić dipl.inž.arh./MSc Arch.		BR. LICENCE/LICENCE NO.: 300 4540 03	OBJEKAT I MESTO GRADNJE/BUILDING NAME AND LOCATION: ZGRADA OPŠTINE PROKUPLJE MUNICIPAL BUILDING PROKUPLJE		
PROJEKTANT/DESIGNER:					
PROJEKTANT/DESIGNER:			NAZIV CRTEŽA/DRAWING NAME: DETALJ D3 - LIFT		
SARADNIK/ASSOCIATE:			DETAIL D3 - ELEVATOR		
RAZMERA/SCALE: 1:50	BR.PROJEKTA/PROJECT NO.:	DATUM/DATE: 01-2020	BROJ CRTEŽA/DRAWING NO: 08	BR. LISTA/SHEET NO.: 2	BR. REV./REV. NO.: REV.0