


LEGENDA / LEGEND:

područje intervencije
 - detalj prikazan posebno
intervention area
- detailed on separate drawing

LEGENDA

Granice parcela
 Predmetni objekat
 Susedni objekti

ODGOVORNI PROJEKTANT/SENIOR DESIGNER: Mirjana Lazić dipl.inž.arh./MSc Arch.		BR. LICENCE/LICENCE NO.: 300 4540 03	PROJEKAT/DESIGN: TENDERSKA DOKUMENTACIJA TENDER DOCUMENTATION		
			INVESTITOR/INVESTOR:		
PROJEKTANT/DESIGNER:			OBJEKAT I MESTO GRADNJE/BUILDING NAME AND LOCATION: ZGRADA OPŠTINE BABUŠNICA MUNICIPALITY BUILDING BABUŠNICA, K.P. br. 253 K.O. Babušnica		
PROJEKTANT/DESIGNER:			NAZIV CRTEŽA/DRAWING NAME: SITUACIONI PLAN SITE PLAN		
SARADNIK/ASSOCIATE:					
RAZMERA/SCALE: 1:100	BR.PROJEKTA/PROJECT NO.:	DATUM/DATE: 01.2020	BR. CRTEŽA/DRAWING NO.: 01	BR. LISTA/SHEET NO.:	BR. REV./REV. NO.: REV.0

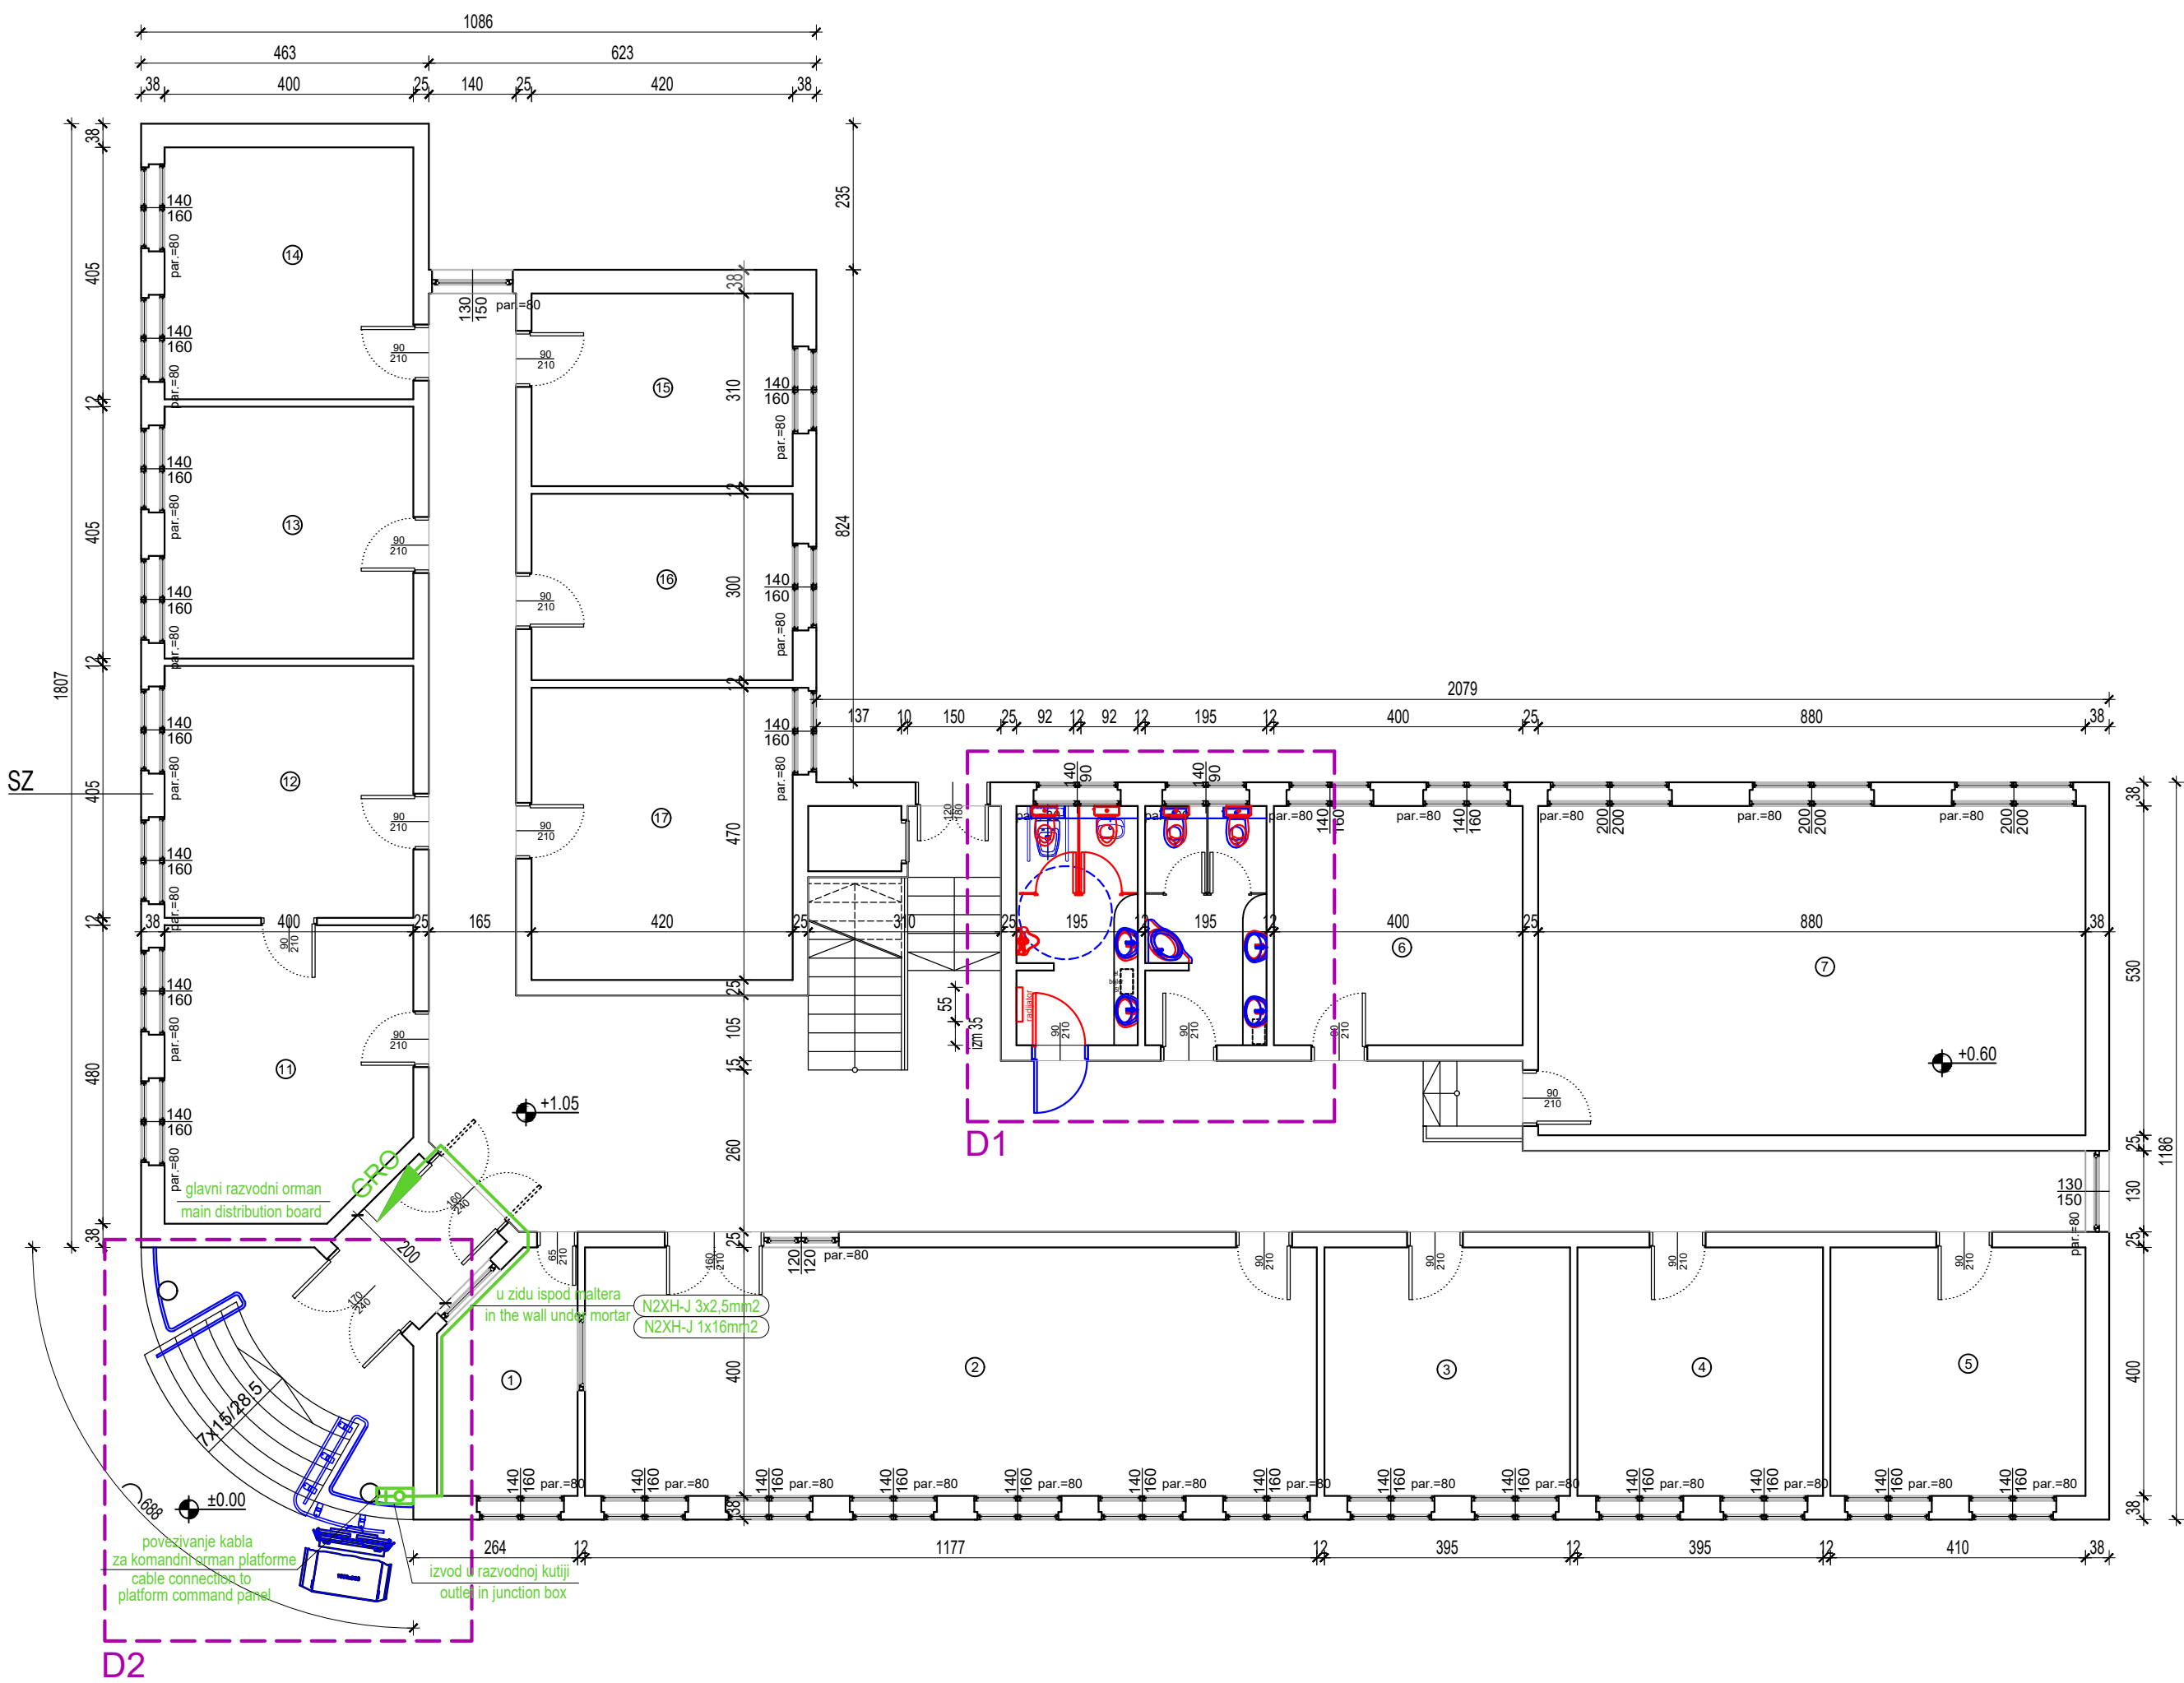


P R I Z E M L J E	
prostorija	P (m ²)
1 portir	8.10
2 uslužni centar	47.10
3 kancelarija	15.80
4 kancelarija	15.80
5 kancelarija	16.40
6 ekonom	15.40
7 arhiva	46.60
hodnik	94.10
WC ženski	7.10
WC muški	7.10
11 kancelarija	18.20
12 kancelarija	16.20
13 kancelarija	16.20
14 kancelarija	16.20
15 kancelarija	13.00
16 kancelarija	12.60
17 kancelarija	19.70
vetrobran	4.00
ukupno:	389.60
ukupna neto površina:	389.60
ukupna bruto površina:	458.00

LEGENDA / LEGEND:


 područje intervencije
- detalj prikazan posebno
intervention area
- detailed on separate drawing

 rušenje / demolition
demontaža / disassembling


 novo / new

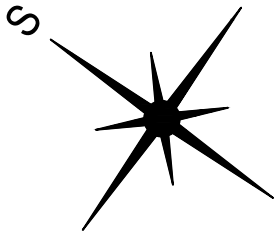

ODGOVORNI PROJEKTANT/SENIOR DESIGNER: Mirjana Lazić dipl.inž.arh./MSc Arch.		BR. LICENCE/LICENCE NO.: 300 4540 03		PROJEKAT/DESIGN: TENDERSKA DOKUMENTACIJA TENDER DOCUMENTATION	
		INVESTITOR/INVESTOR:		OBJEKAT I MESTO GRADNJE/BUILDING NAME AND LOCATION: ZGRADA OPŠTINE BABUŠNICA MUNICIPALITY BUILDING BABUŠNICA K.P. br. 253 K.O. Babušnica	
PROJEKTANT/DESIGNER:		PROJEKTANT/DESIGNER:		NAZIV CRTEŽA/DRAWING NAME: OSNOVA PRIZEMLJE - PLAN INTERVENCIJE GROUND FLOOR LAYOUT - INTERVENTION PLAN	
SARADNIK/ASSOCIATE:		SARADNIK/ASSOCIATE:		BROJ CRTEŽA/DRAWING NO.: 02	
RAZMERA/SCALE: 1:100		BR.PROJEKTA/PROJECT NO.: 01.2020		BR. LISTA/SHEET NO.: REV.0	

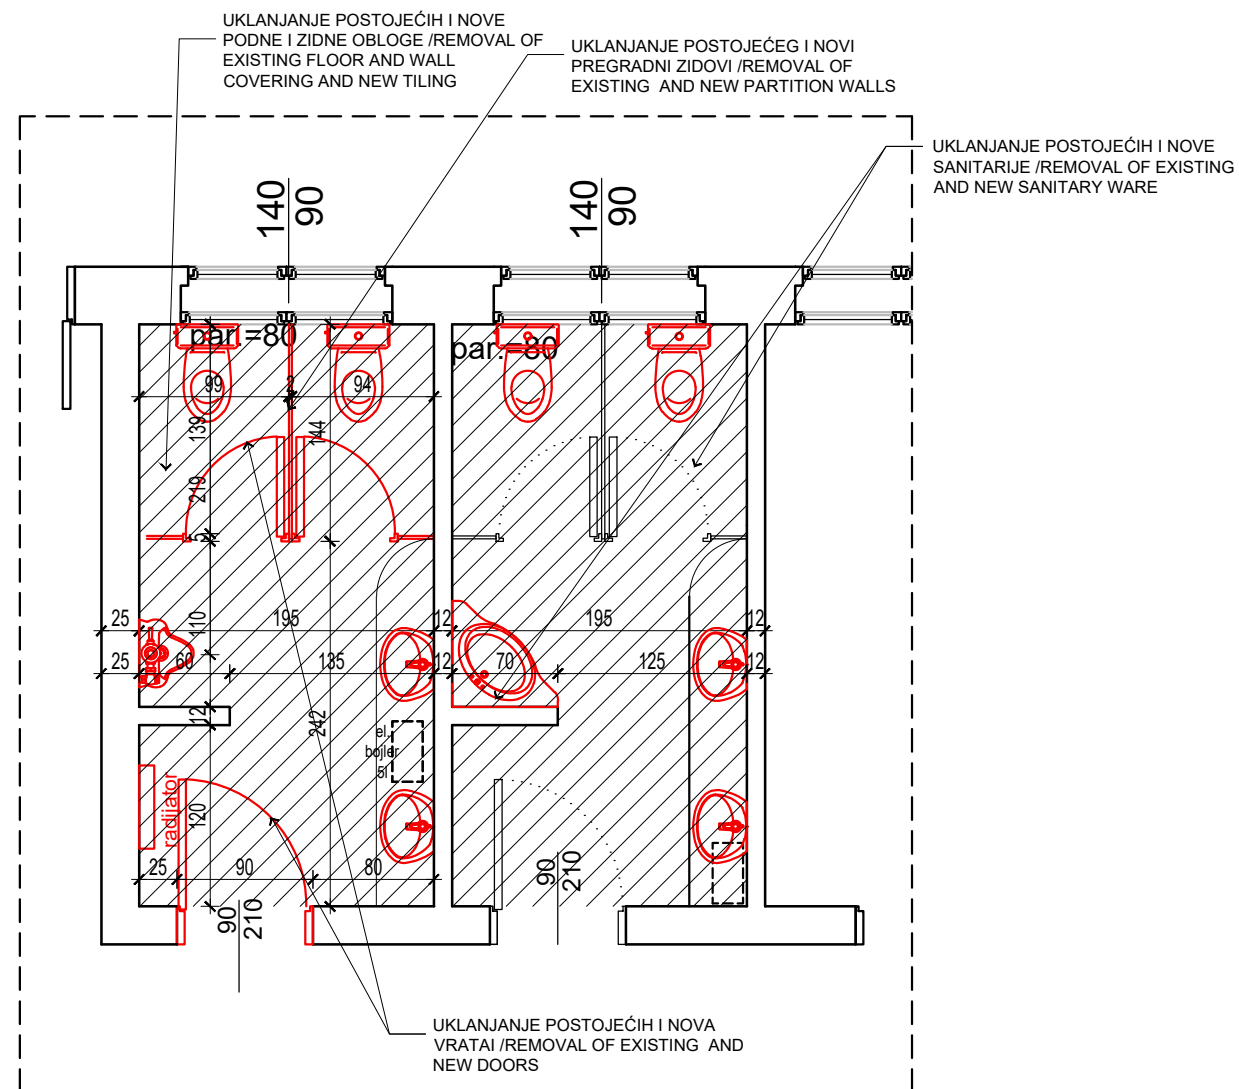


POSTOJEĆE STANJE
SA PLANOM RUŠENJA
EXISTING STATE
WITH DEMOLITION PLAN

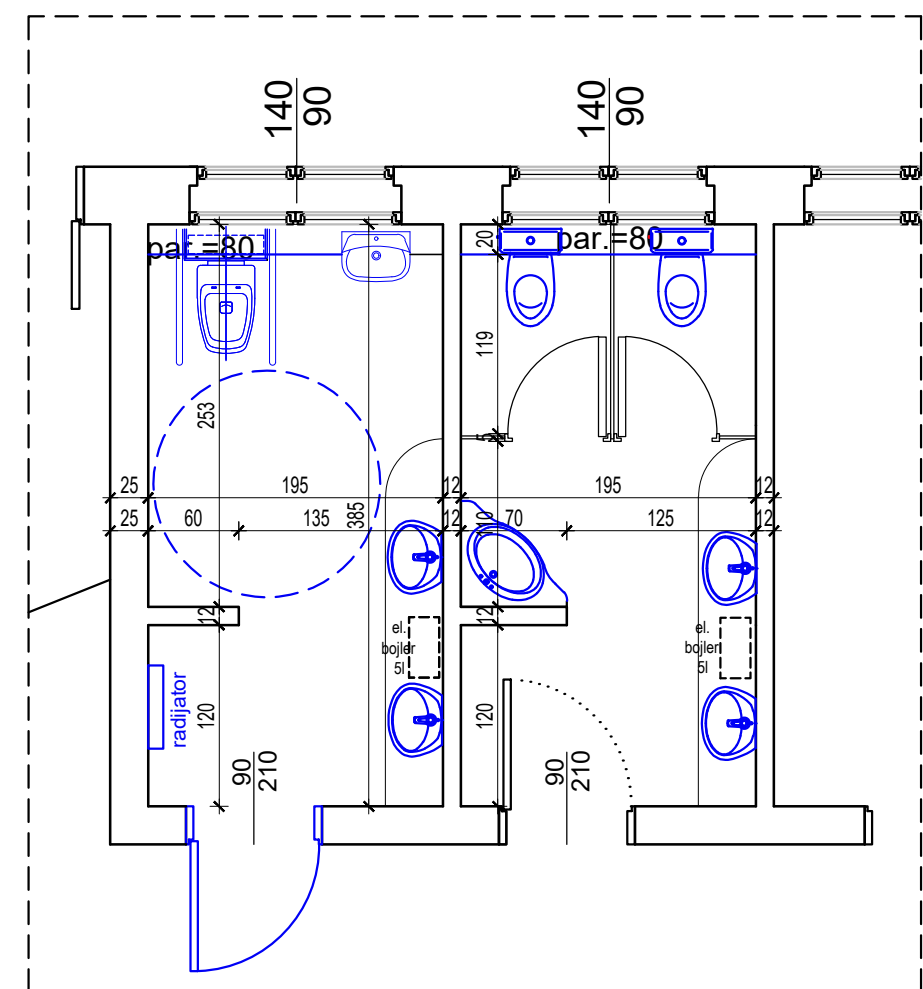


NOVOPROJEKTOVANO
NEWLY DESIGNED

LEGENDA / LEGEND:

-  rušenje / demolition
demontaža / disassembling
-  trotoar za rušenje
pavement to be demolished
-  novo / new
-  nov trotoar
new pavement


Predvideti: -novu elektroinstalaciju sa rasvetom i SOS
signalizacijom
/ new electrical instalation with lights and SOS signalling
-novu hldroinstalaciju -zamenu razvoda i sanitarija
/ new hydro instalation - replacement of pipes and sanitary
ware


		PROJEKAT/DESIGN: TENDERSKA DOKUMENTACIJA TENDER DOCUMENTATION		
		INVESTITOR/INVESTOR:		
ODGOVORNI PROJEKTANT/SENIOR DESIGNER: Mirjana Lazić dipl.inž.arh./MSc Arch.		BR. LICENCE/LICENCE NO.: 300 4540 03	OBJEKAT I MESTO GRADNJE/BUILDING NAME AND LOCATION: ZGRADA OPŠTINE BABUŠNICA MUNICIPALITY BUILDING BABUŠNICA K.P. br. 253 K.O. Babušnica	
PROJEKTANT/DESIGNER:				
PROJEKTANT/DESIGNER:			NAZIV CRTEŽA/DRAWING NAME: DETALJ D1 - TOALET DETAIL D1 - TOILET	
SARADNIK/ASSOCIATE:				
RAZMERA/SCALE: 1:50	BR.PROJEKTA/PROJECT NO.:	DATUM/DATE: 01-2020	BROJ CRTEŽA/DRAWING NO.: 03	BR. LISTA/SHEET NO.: REV.0

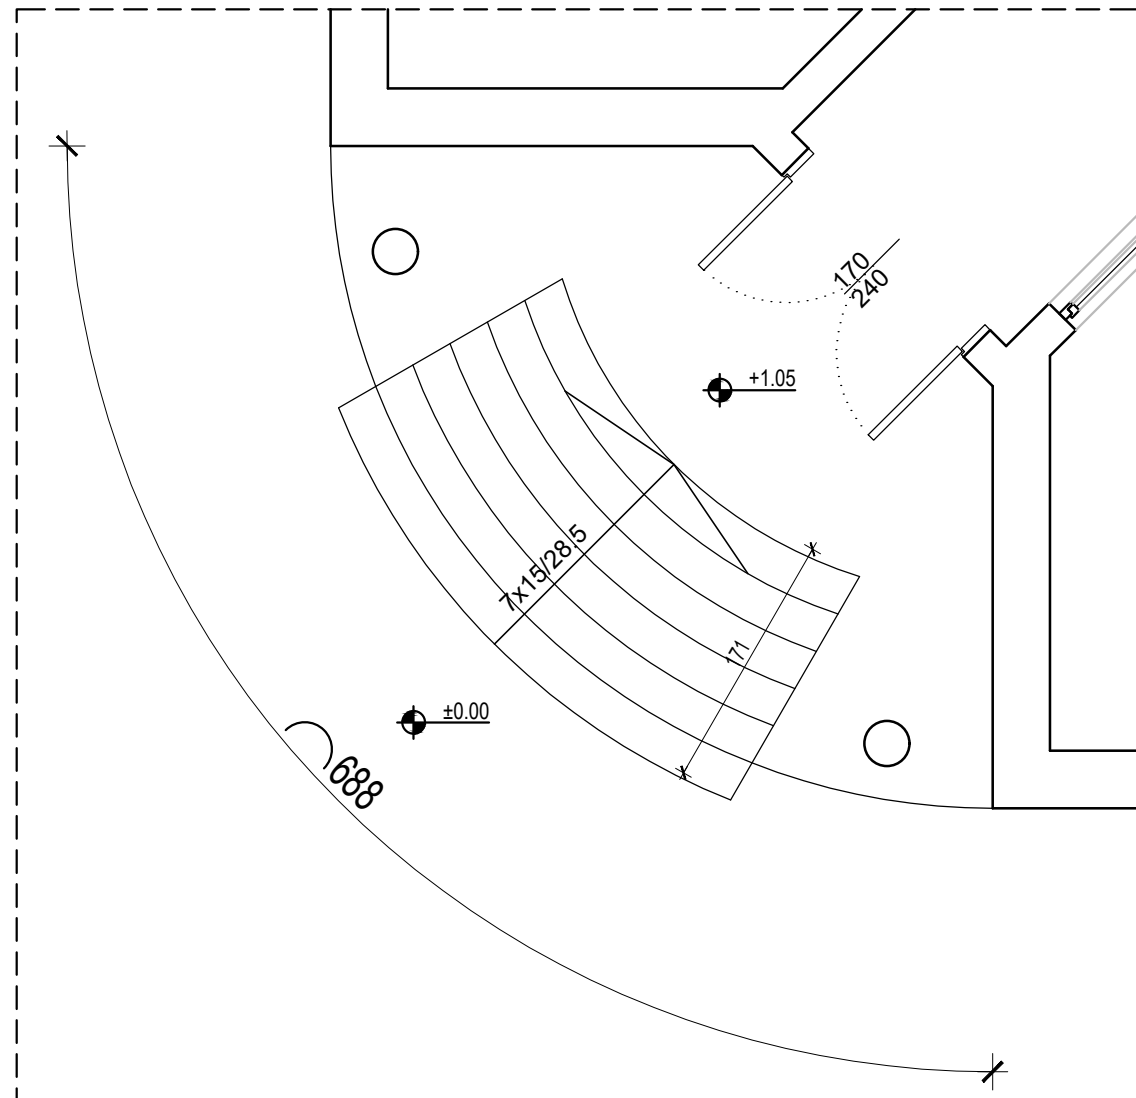

POSTOJEĆE STANJE
SA PLANOM RUŠENJA
EXISTING STATE
WITH DEMOLITION PLAN

 LEGENDA / LEGEND:


-  rušenje / demolition
demontaža / disassembling
-  trotoar za rušenje
pavement to be demolished
-  novo / new
-  nov trotoar
new pavement

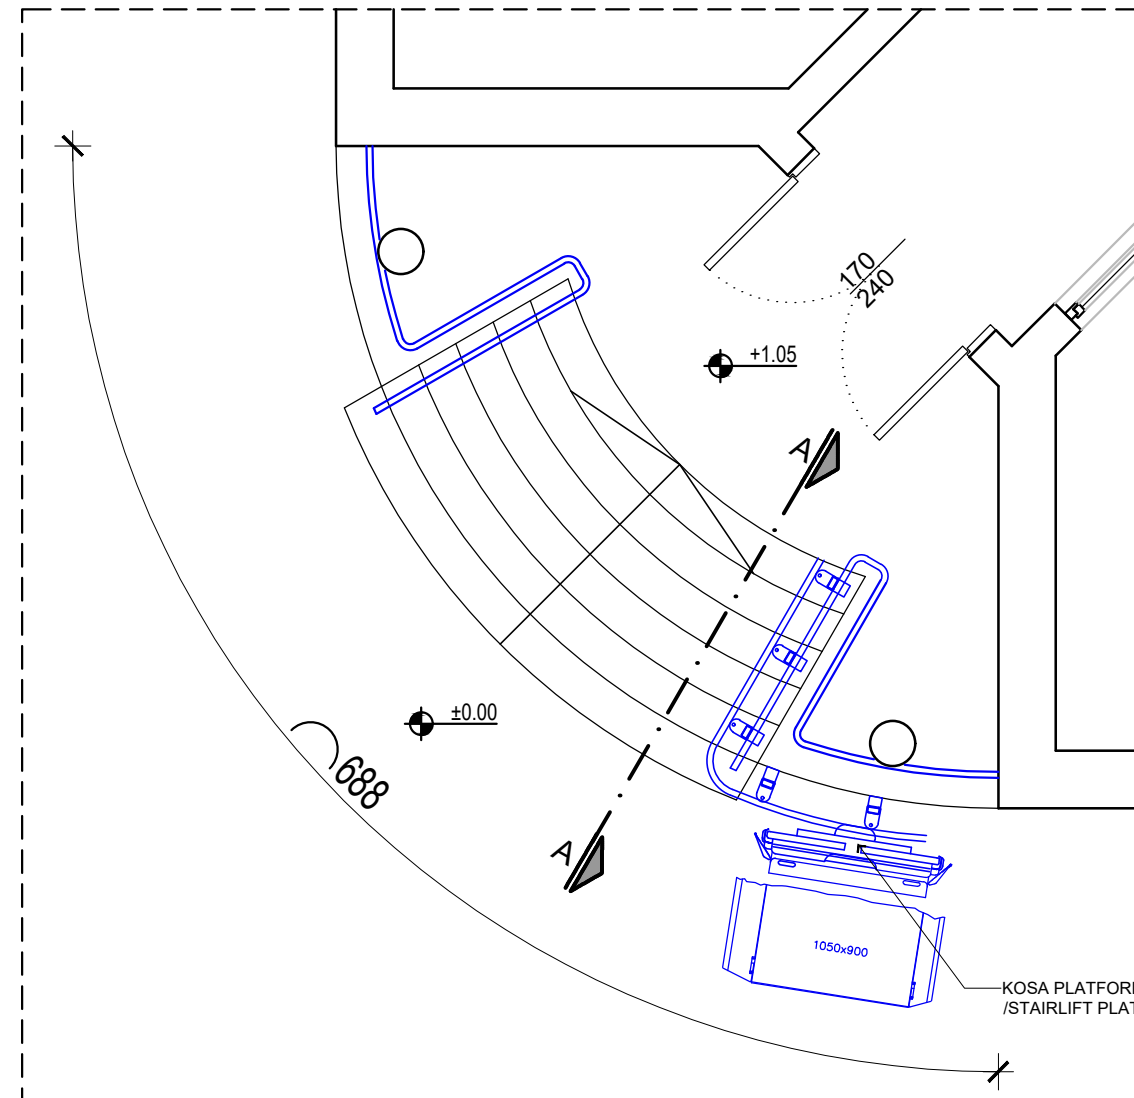


NOVOPROJEKTOVANO
NEWLY DESIGNED


		PROJEKAT/DESIGN: TENDERSKA DOKUMENTACIJA TENDER DOCUMENTATION		
		INVESTITOR/INVESTOR:		
ODGOVORNI PROJEKTANT/SENIOR DESIGNER: Mirjana Lazić dipl.inž.arh./MSc Arch.		BR. LICENCE/LICENCE NO.: 300 4540 03	OBJEKAT I MESTO GRADNJE/BUILDING NAME AND LOCATION: ZGRADA OPŠTINE BABUŠNICA MUNICIPALITY BUILDING BABUŠNICA K.P. br. 253 K.O. Babušnica	
PROJEKTANT/DESIGNER:				
PROJEKTANT/DESIGNER:			NAZIV CRTEŽA/DRAWING NAME: DETALJ D2 - KOSA PLATFORMA - OSNOVE DETAIL D2 - STAIRLIFT PLATFORM - LAYOUT	
SARADNIK/ASSOCIATE:				
RAZMERA/SCALE: 1:50	BR.PROJEKTA/PROJECT NO.:	DATUM/DATE: 01-2020	BROJ CRTEŽA/DRAWING NO.: 04	BR. LISTA/SHEET NO.: REV.0

 LEGENDA / LEGEND:

 novo / new

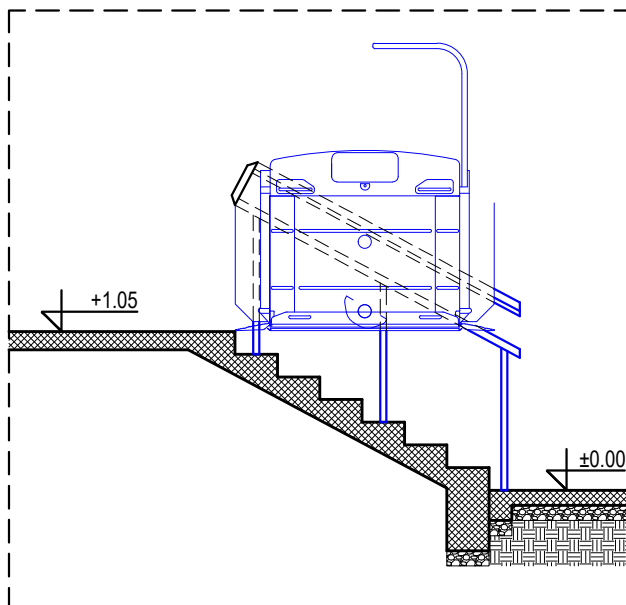

LEGENDA / LEGEND:

 armirani beton / reinforced concrete



 nabijena zemlja / compact soil

 postojeći teren / existing level line

 hidroizolacioni premaz / waterproofing layer

			PROJEKAT/DESIGN: TENDERSKA DOKUMENTACIJA TENDER DOCUMENTATION		
			INVESTITOR/INVESTOR:		
ODGOVORNI PROJEKTANT/SENIOR DESIGNER: Mirjana Lazić dipl.inž.arh./MSc Arch.		BR. LICENCE/LICENCE NO.: 300 4540 03	OBJEKAT I MESTO GRADNJE/BUILDING NAME AND LOCATION: ZGRADA OPŠTINE BABUŠNICA MUNICIPALITY BUILDING BABUŠNICA K.P. br. 253 K.O. Babušnica		
PROJEKTANT/DESIGNER:					
PROJEKTANT/DESIGNER:			NAZIV CRTEŽA/DRAWING NAME: DETALJ D2 - KOSA PLATFORMA - PRESEK DETAIL D2 - STAIRLIFT PLATFORM - SECTION		
SARADNIK/ASSOCIATE:					
RAZMERA/SCALE: 1:50	BR.PROJEKTA/PROJECT NO.:	DATUM/DATE: 01-2020	BRJ CRTEŽA/DRAWING NO: 05	BR. LISTA/SHEET NO.:	BR. REV./REV. NO.: REV.0